

PROJECT:

PROPOSED BRANCH LAYOUT OF CENTRAL
BANK OF INDIA PURAINI BRANCH

SHEET TITLE:

ELECTRICAL LAYOUT PLAN

DLT:


Ar. A.K.SINGH

North:




DRG. NO.
EP 01

DATE:
05.05.2025

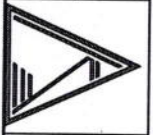

AKS DESIGN

ARCHITECTS ENGINEERS VALUERS ESTIMATORS INTERIOR DESIGNERS
INDRAPURI, SHIV MANDIR ROAD, PATNA 800024
Mob. 9835812470, email. ar.aks@yahoo.com, website. www.aksdesign.in

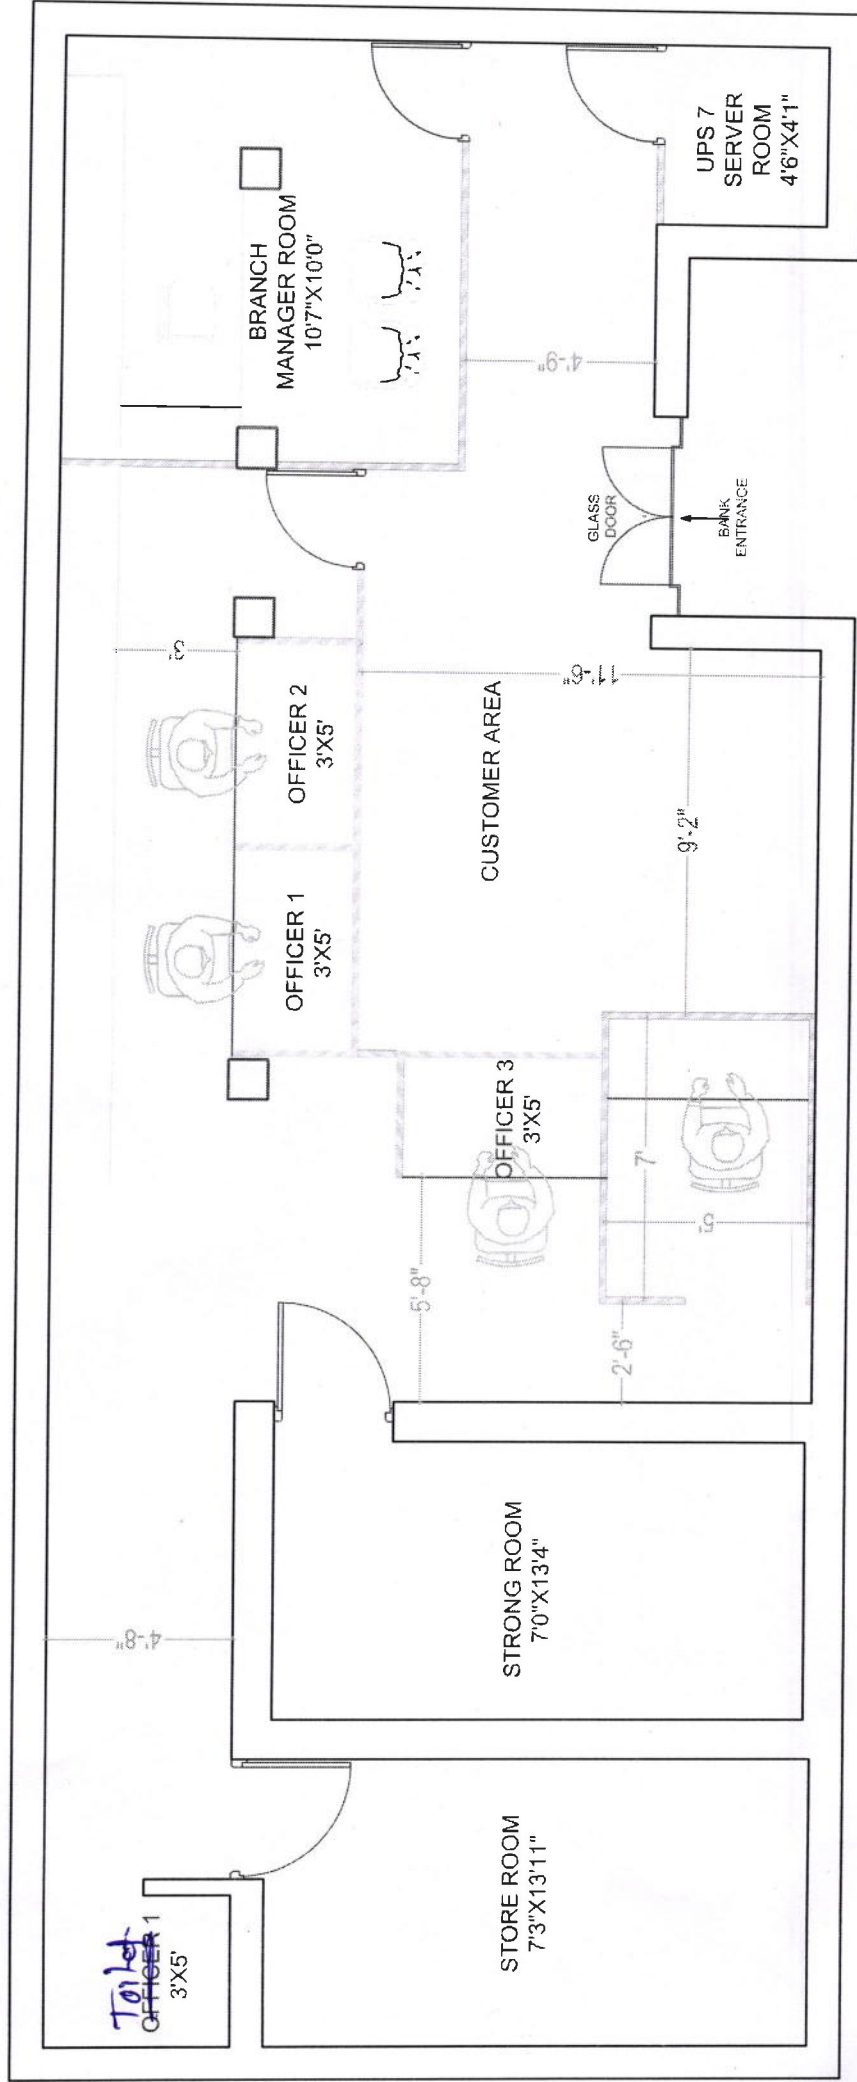

PROJECT:

PROPOSED BRANCH LAYOUT OF CENTRAL
BANK OF INDIA PURAINI BRANCH

SHEET TITLE:

LAYOUT PLAN

DLT:


Ar. A.K.SINGH

North:



DRG. NO.
CP 01

DATE:
05.05.2025

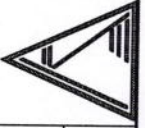

AKS DESIGN

ARCHITECTS ENGINEERS VALUERS ESTIMATORS INTERIOR DESIGNERS
INDRAPURI, SHIV MANDIR ROAD, PATNA 800024
Mob. 9835812470, email. ar.aks@yahoo.com, website. www.aksdesign.in